


Figure 13.5

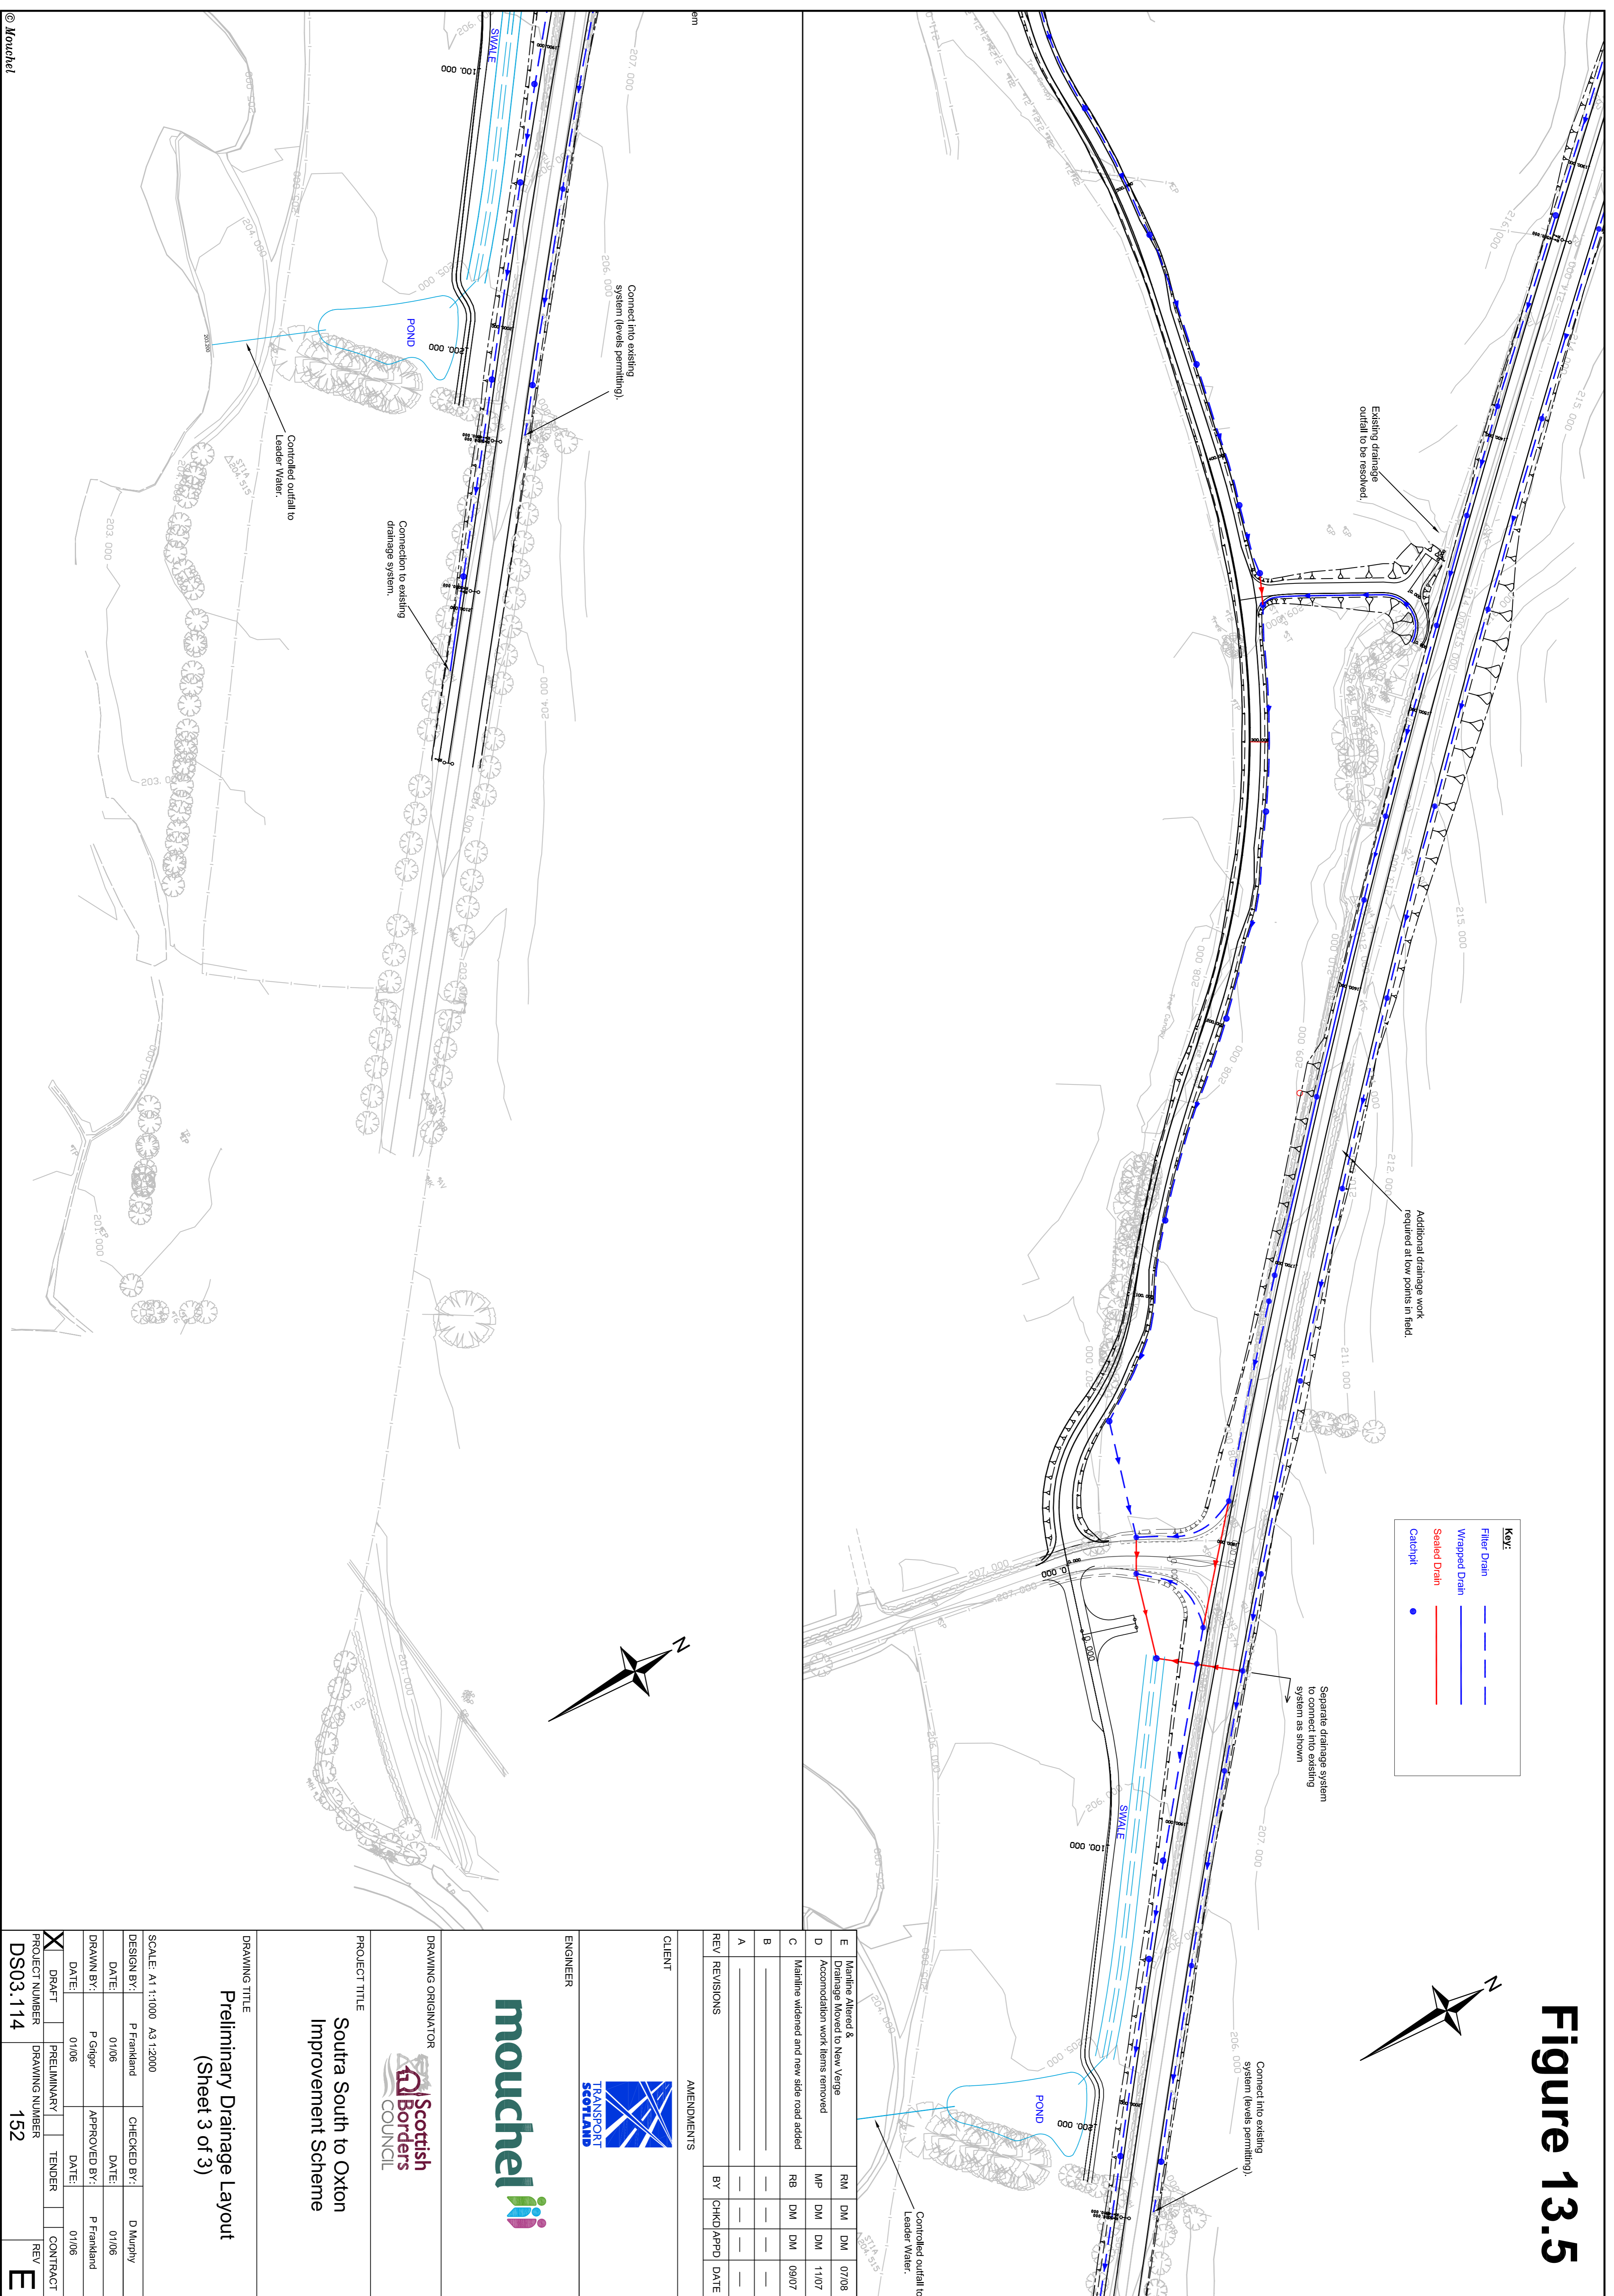

REV	REVISIONS	BY	CHKD	APPD	DATE
E	Mainline Altered & Drainage Moved to New Verge	RM	DM	DM	07/08
D	Accommodation work items removed	MP	DM	DM	11/07
C	Mainline widened and new side road added	RB	DM	DM	09/07
B					
A					

**CLIENT**

**AMENDMENTS**

**ENGINEER**

**TRANSPORT SCOTLAND**

**mouchel**

**SCOTTISH BORDERS COUNCIL**

**DRAWING ORIGINATOR**

**PROJECT TITLE**

**Soutra South to Oxton Improvement Scheme**

**DRAWING TITLE**

**Preliminary Drainage Layout (Sheet 3 of 3)**

**SCALE:** A1 1:1000 A3 1:2000

<b>DESIGN BY:</b>	P Frankland	<b>CHECKED BY:</b>	D Murphy
<b>DATE:</b>	01/08	<b>DATE:</b>	01/08
<b>DRAWN BY:</b>	P Giggor	<b>APPROVED BY:</b>	P Frankland
<b>DATE:</b>	01/08	<b>DATE:</b>	01/08

<input checked="" type="checkbox"/> <b>DRAFT</b>	<input type="checkbox"/> <b>PRELIMINARY</b>	<input type="checkbox"/> <b>TENDER</b>	<input type="checkbox"/> <b>CONTRACT</b>
<b>PROJECT NUMBER</b>	<b>DRAWING NUMBER</b>	<b>REV</b>	
DS03_114	152	<b>E</b>	